

NOTES				
1. ALL DIMENSIONS ARE IN MM & ELEVATIONS IN METERS UNLESS STATED OTHERWISE.				
2. THE DRAWINGS IS THE PROPERTY OF MATHUR UGAM & ASSOCIATES AND NOT TO BE USED OR REPRODUCED WITHOUT THEIR PERMISSION				
3. UNLESS NOTED OTHERWISE WINDOW / DOOR/ ROLLING SHUTTER LOCATION SHALL BE AT CENTER BETWEEN GRIDS.				
4. THIS DRAWING SHALL BE READ IN CONJUNCTION WITH CONTRACT TERMS AND CONDITIONS, SPECIFICATION AND SCHEDULE OF ITEMS.				
IMPORTANT NOTE				
1. CONSTRUCTION CAN COMMENCE ONLY AFTER THE VERIFICATION OF LOCATION CO-ORDINATES OF THE BUILDING. THE SAME SHALL BE VERIFIED AT SITE WITH RESPECT TO LATEST PLOT PLAN, APPROVED MECH GAD, ARCHITECTURAL AND CIVIL DRAWINGS.				
2. FAN HOOK & CONDUIT PIPE ETC. TO BE PROVIDED WITH THE CONSULTATION OF ELECT. BRANCH.				
3.				

DOOR, WINDOW & VENTILATION SCHEDULE				
S.N.	TYPE	SIZE		
1	D1	900X2100MM		
2	D2	1000X2100MM		
3	D3	750X2100MM		
4	D4	2000X2100MM		
5	W	1200X1500MM		
6	W1	1500X1500MM		
7	W2	2000X1500MM		
8	W3	1140X1500MM		
9	W4	3900X1500MM		
10	V	600X600MM		
11	V1	900X600MM		

COVERED AREA = 427 SQM

REV.	DATE	DESCRIPTION	DRN.	APPROVED BY
OWNER				
TCIL				

PROJECT

PROPOSED HOSTEL BUILDING (G+3)
BLOCK-I NMA, SILVASA

ARCHITECT



MATHUR UGAM & ASSOCIATES
A/294,2RD FLOOR, SAFDARJUNG ENCLAVE,
NEW DELHI-110029
PH. NO.- (011) 41072283, 26100971
FAX No.:-26185711
Email - mathurugam@gmail.com

DRAWN BY	DESIGN BY	APPROVED BY	CHECKED BY
MOHD. SHADAB KHAN	AR. ASHISH MATHUR	AR. ASHISH MATHUR	AR. ASHISH MATHUR

TITLE

GROUND FLOOR PLAN

DRWAING TYPE	SCALE	DRAWING NO.
TENDER DRAWING	NTS	MUA/AR/SLVSA/GN/01
		DATE OF ISSUE

GROUND FLOOR PLAN

NOTES

1. ALL DIMENSIONS ARE IN MM & ELEVATIONS IN METERS UNLESS STATED OTHERWISE.

2. THE DRAWINGS IS THE PROPERTY OF MATHUR UGAM & ASSOCIATES AND NOT TO BE USED OR REPRODUCED WITHOUT THEIR PERMISSION

3. UNLESS NOTED OTHERWISE WINDOW / DOOR/ ROLLING SHUTTER LOCATION SHALL BE AT CENTER BETWEEN GRIDS.

4. THIS DRAWING SHALL BE READ IN CONJUNCTION WITH CONTRACT TERMS AND CONDITIONS, SPECIFICATION AND SCHEDULE OF ITEMS.

IMPORTANT NOTE

1. CONSTRUCTION CAN COMMENCE ONLY AFTER THE VERIFICATION OF LOCATION CO-ORDINATES OF THE BUILDING. THE SAME SHALL BE VERIFIED AT SITE WITH RESPECT TO LATEST PLOT PLAN, APPROVED MECH GAD, ARCHITECTURAL AND CIVIL DRAWINGS.

2. FAN HOOK & CONDUIT PIPE ETC. TO BE PROVIDED WITH THE CONSULTATION OF ELECT. BRANCH.

3.

DOOR, WINDOW & VENTILATION SCHEDULE				
S.N.	TYPE	SIZE		
1	D1	900X2100MM		
2	D2	1000X2100MM		
3	D3	750X2100MM		
4	D4	2000X2100MM		
5	W	1200X1500MM		
6	W1	1500X1500MM		
7	W2	2000X1500MM		
8	W3	1140X1500MM		
9	W4	3900X1500MM		
10	V	600X600MM		
11	V1	900X600MM		

COVERED AREA = 384 SQM

REV.	DATE	DESCRIPTION	DRN.	APPROVED BY
OWNER				
TCIL				

PROJECT

PROPOSED HOSTEL BUILDING (G+3)
BLOCK-I NMA, SILVASA

ARCHITECT


MATHUR UGAM & ASSOCIATES
A/294,2RD FLOOR, SAFDARJUNG ENCLAVE,
NEW DELHI-110029
PH. NO.-(011) 41072283, 26100971
FAX No.:-26185711
Email - mathurugam@gmail.com

DRAWN BY	DESIGN BY	APPROVED BY	CHECKED BY
MOHD. SHADAB KHAN	AR. ASHISH MATHUR	AR. ASHISH MATHUR	AR. ASHISH MATHUR

TITLE

TYPICAL 1-3 FLOOR PLAN

DRWAING TYPE	SCALE	DRAWING NO.
TENDER DRAWING	NTS	MUA/AR/SLVSA/GN/02
		DATE OF ISSUE

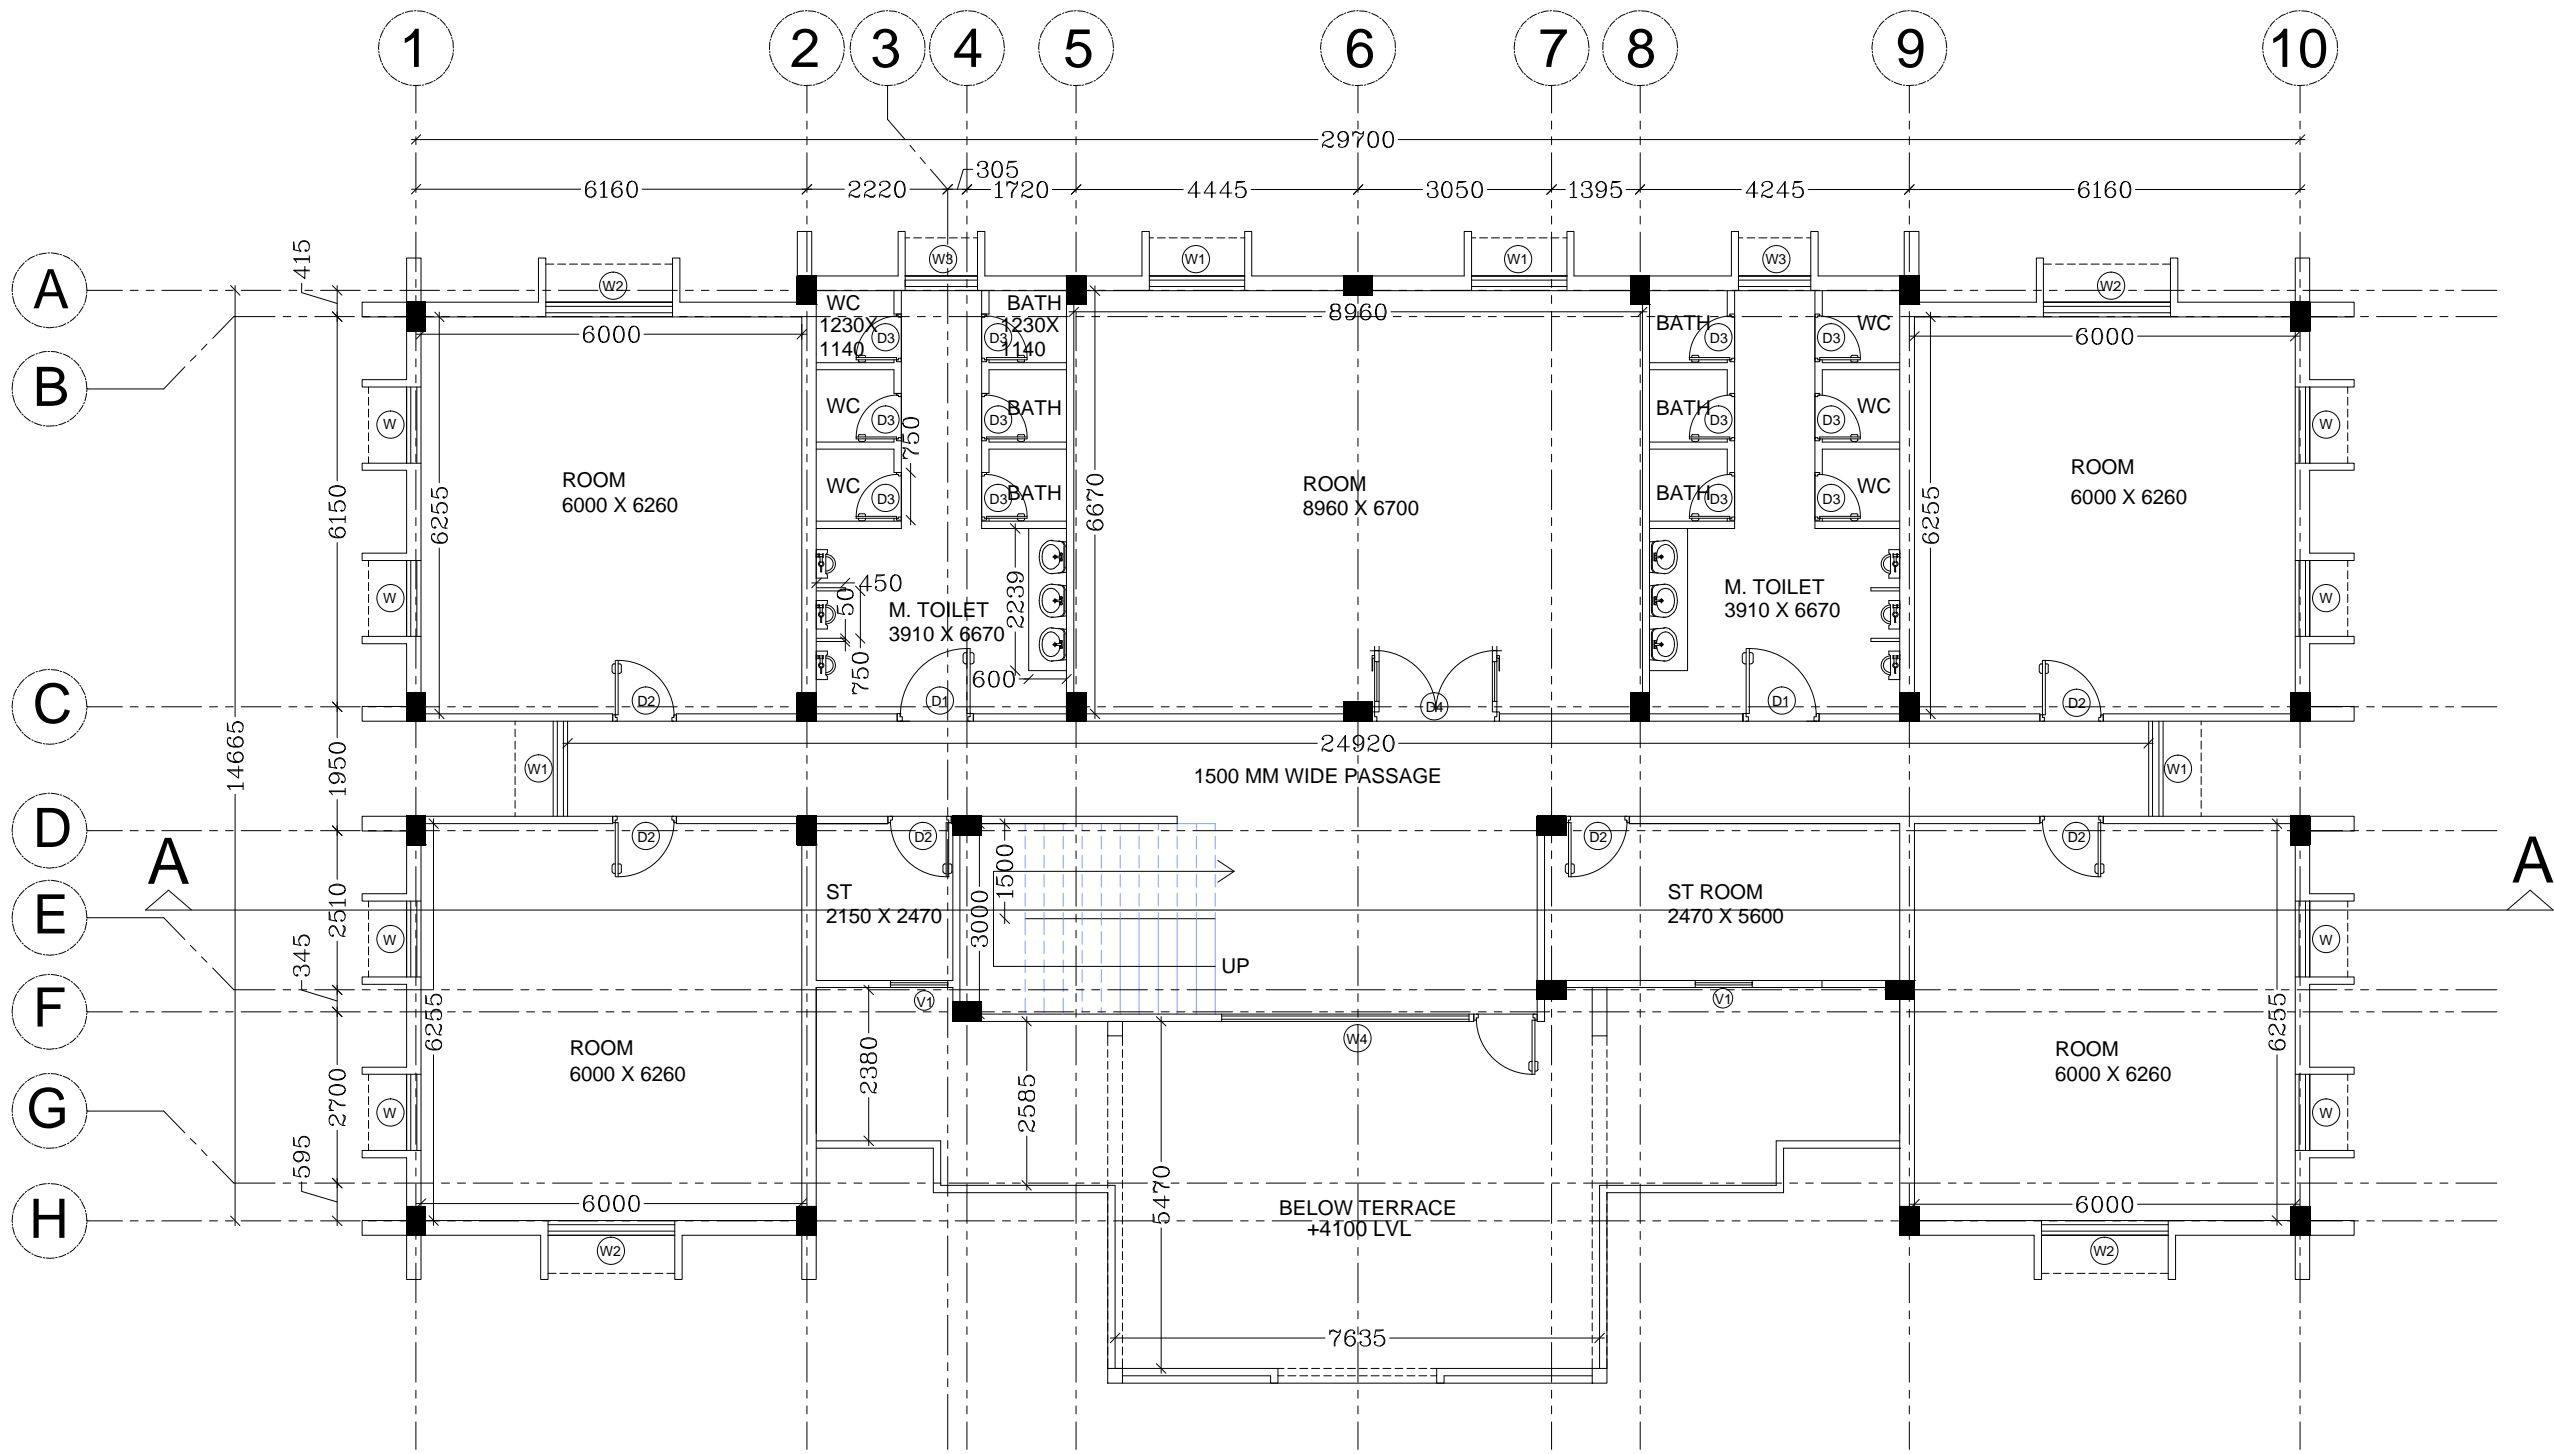

TYPICAL 1-3 FLOOR PLAN

NOTES

1. ALL DIMENSIONS ARE IN MM & ELEVATIONS IN METERS UNLESS STATED OTHERWISE.

2. THE DRAWINGS IS THE PROPERTY OF MATHUR UGAM & ASSOCIATES AND NOT TO BE USED OR REPRODUCED WITHOUT THEIR PERMISSION

3. UNLESS NOTED OTHERWISE WINDOW / DOOR/ ROLLING SHUTTER LOCATION SHALL BE AT CENTER BETWEEN GRIDS.

4. THIS DRAWING SHALL BE READ IN CONJUNCTION WITH CONTRACT TERMS AND CONDITIONS, SPECIFICATION AND SCHEDULE OF ITEMS.

IMPORTANT NOTE

1. CONSTRUCTION CAN COMMENCE ONLY AFTER THE VERIFICATION OF LOCATION CO-ORDINATES OF THE BUILDING. THE SAME SHALL BE VERIFIED AT SITE WITH RESPECT TO LATEST PLOT PLAN, APPROVED MECH. GAD, ARCHITECTURAL AND CIVIL DRAWINGS.

2. FAN HOOK & CONDUIT PIPE ETC. TO BE PROVIDED WITH THE CONSULTATION OF ELECT. BRANCH.

3.

DOOR, WINDOW & VENTILATION SCHEDULE

S.N.	TYPE	SIZE		
1	D1	900X2100MM		
2	D2	1000X2100MM		
3	D3	750X2100MM		
4	D4	2000X2100MM		
5	W	1200X1500MM		
6	W1	1500X1500MM		
7	W2	2000X1500MM		
8	W3	1140X1500MM		
9	W4	3900X1500MM		
10	V	600X600MM		
11	V1	900X600MM		

COVERED AREA = 384 SQM

REV.	DATE	DESCRIPTION	DRN.	APPROVED BY
OWNER				

TCIL

PROJECT
PROPOSED HOSTEL BUILDING (G+3) BLOCK-I NMA, SILVASA

ARCHITECT




MATHUR UGAM & ASSOCIATES
A/294,2RD FLOOR, SAFDARJUNG ENCLAVE,
NEW DELHI-110029
PH. NO.- (011) 41072283, 26100971
FAX No.: -26185711
Email - mathurugam@gmail.com

DRAWN BY	DESIGN BY	APPROVED BY	CHECKED BY
MOHD. SHADAB KHAN	AR. ASHISH MATHUR	AR. ASHISH MATHUR	AR. ASHISH MATHUR

TITLE
TERRACE FLOOR PLAN

DRWAING TYPE	SCALE	DRAWING NO.
TENDER DRAWING	NTS	MUA/AR/SLVSA/GN/03
		DATE OF ISSUE

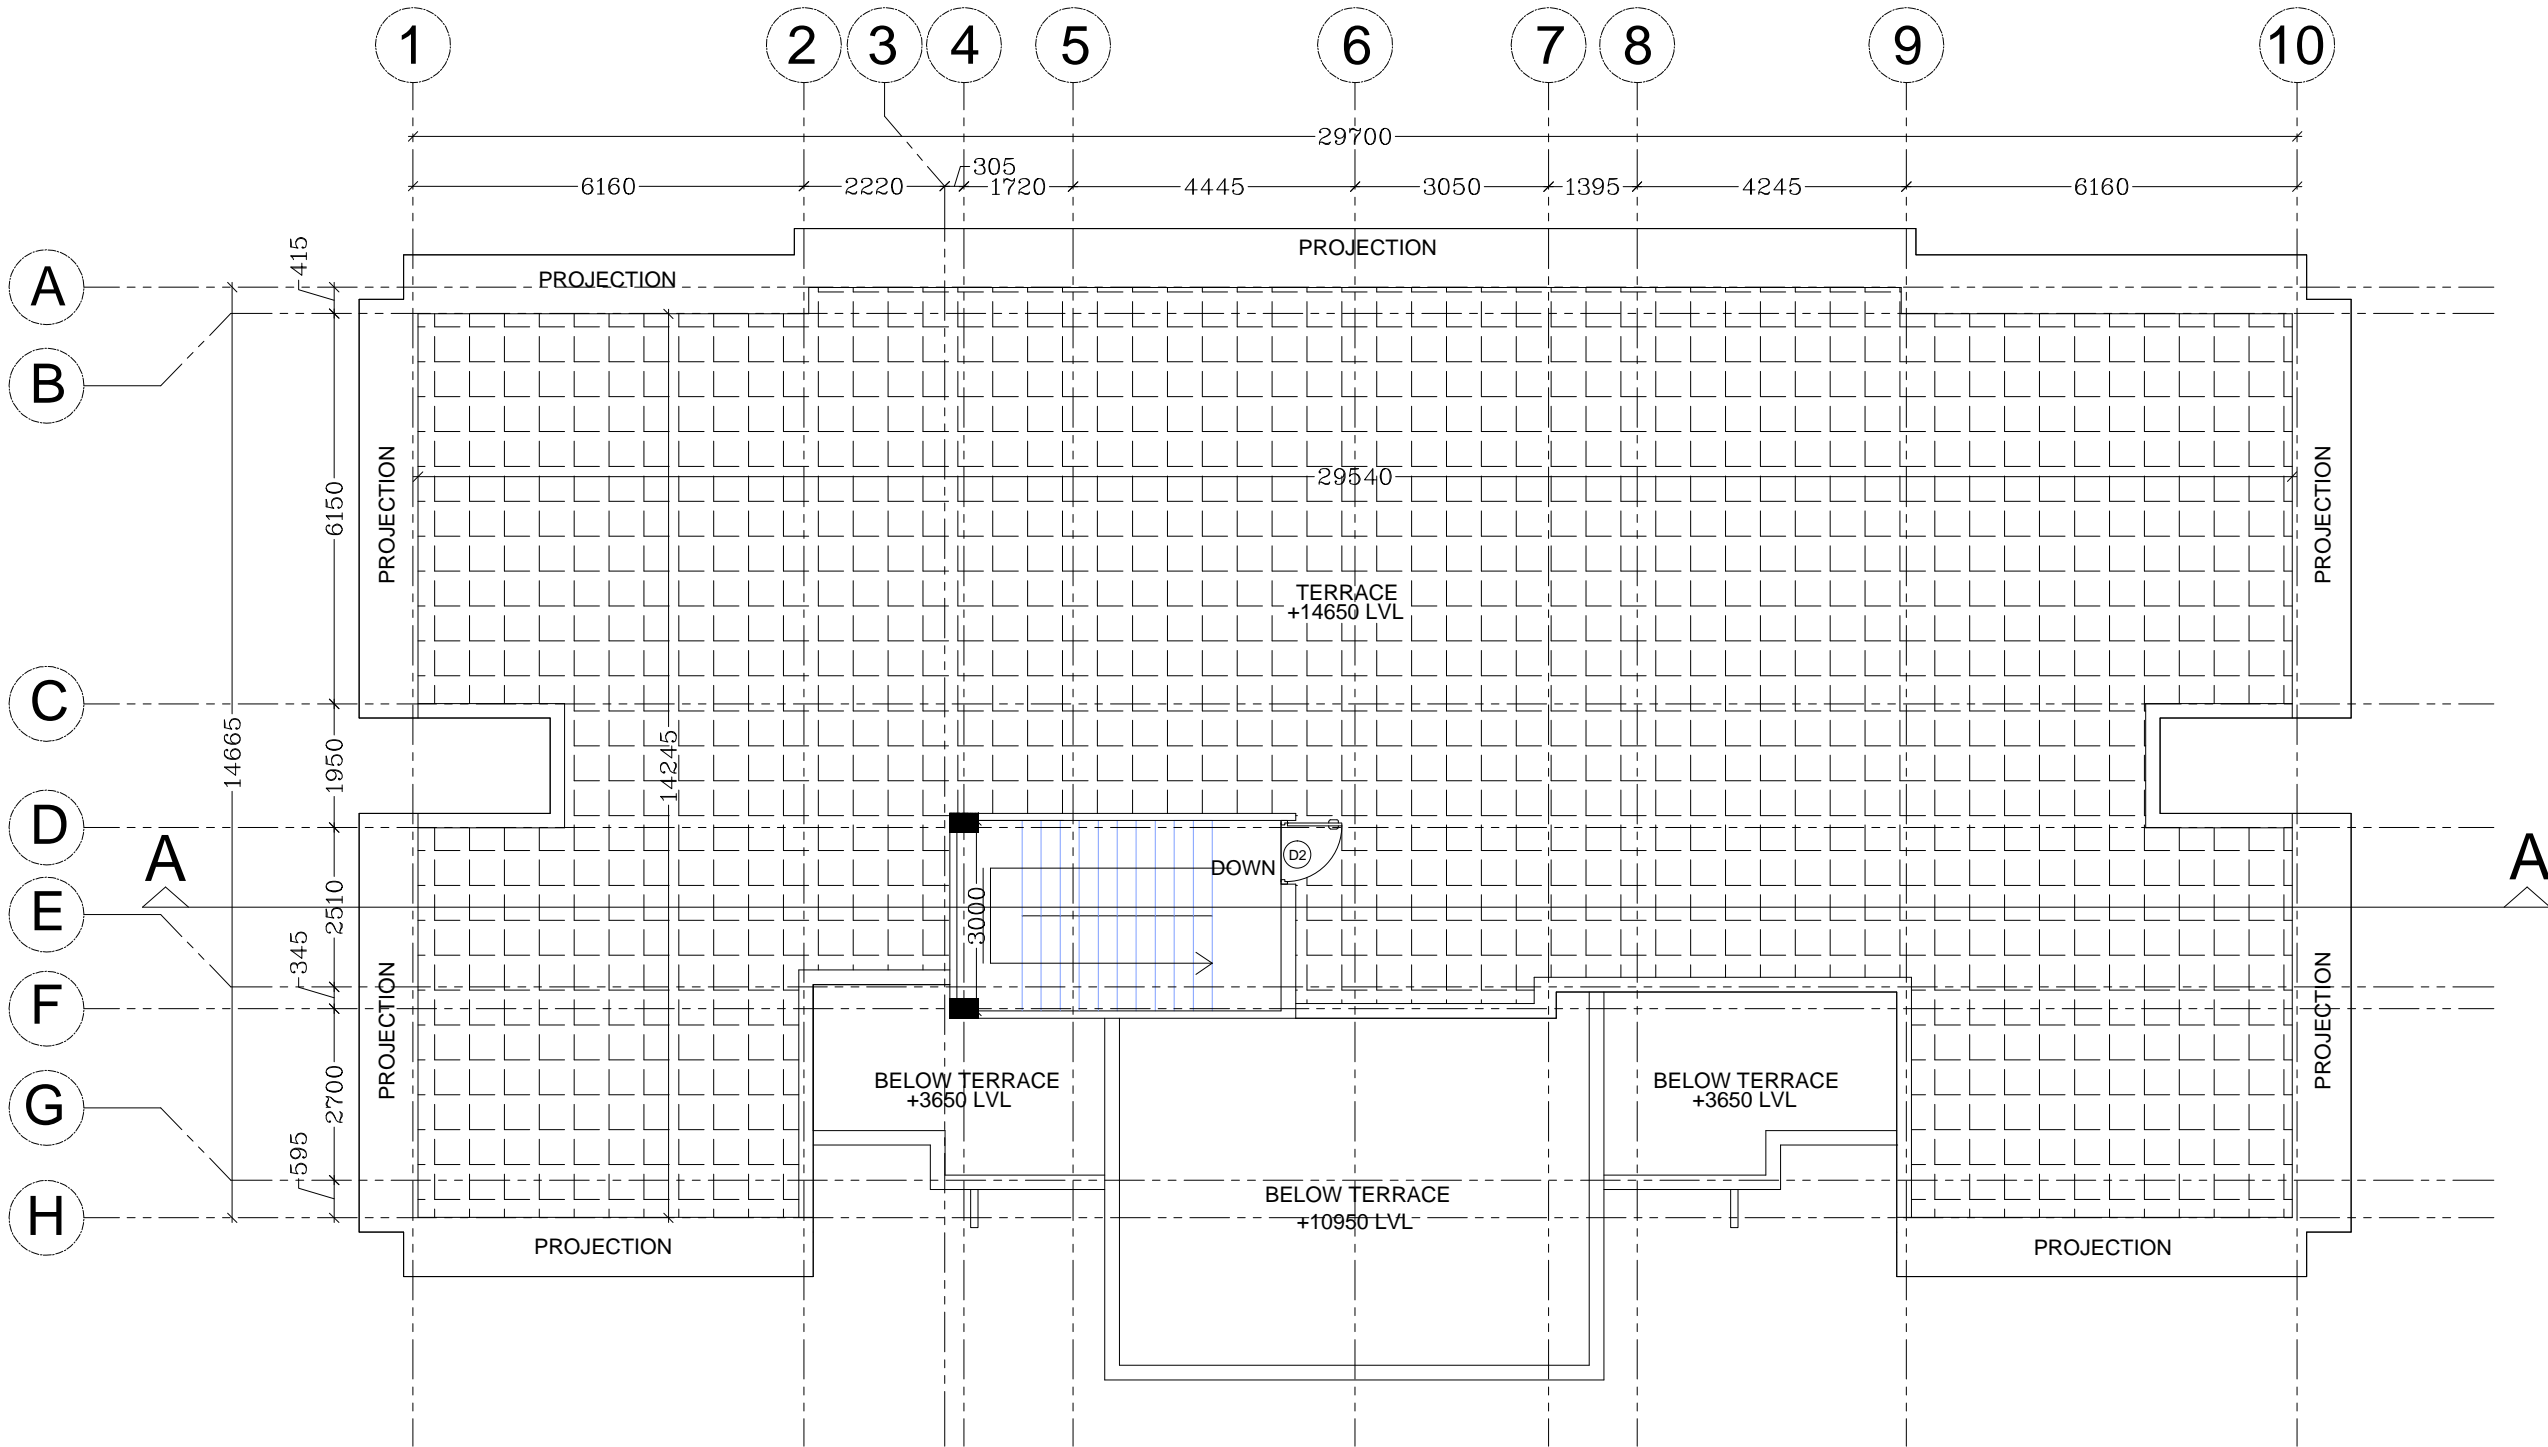

TERRACE FLOOR PLAN

NOTES

1. ALL DIMENSIONS ARE IN MM & ELEVATIONS IN METERS UNLESS STATED OTHERWISE.

2. THE DRAWINGS IS THE PROPERTY OF MATHUR UGAM & ASSOCIATES AND NOT TO BE USED OR REPRODUCED WITHOUT THEIR PERMISSION

3. UNLESS NOTED OTHERWISE WINDOW / DOOR/ ROLLING SHUTTER LOCATION SHALL BE AT CENTER BETWEEN GRIDS.


4. THIS DRAWING SHALL BE READ IN CONJUNCTION WITH CONTRACT TERMS AND CONDITIONS, SPECIFICATION AND SCHEDULE OF ITEMS.

IMPORTANT NOTE


1. CONSTRUCTION CAN COMMENCE ONLY AFTER THE VERIFICATION OF LOCATION CO-ORDINATES OF THE BUILDING. THE SAME SHALL BE VERIFIED AT SITE WITH RESPECT TO LATEST PLOT PLAN, APPROVED MECH GAD, ARCHITECTURAL AND CIVIL DRAWINGS.

2. FAN HOOK & CONDUIT PIPE ETC. TO BE PROVIDED WITH THE CONSULTATION OF ELECT. BRANCH.

3.

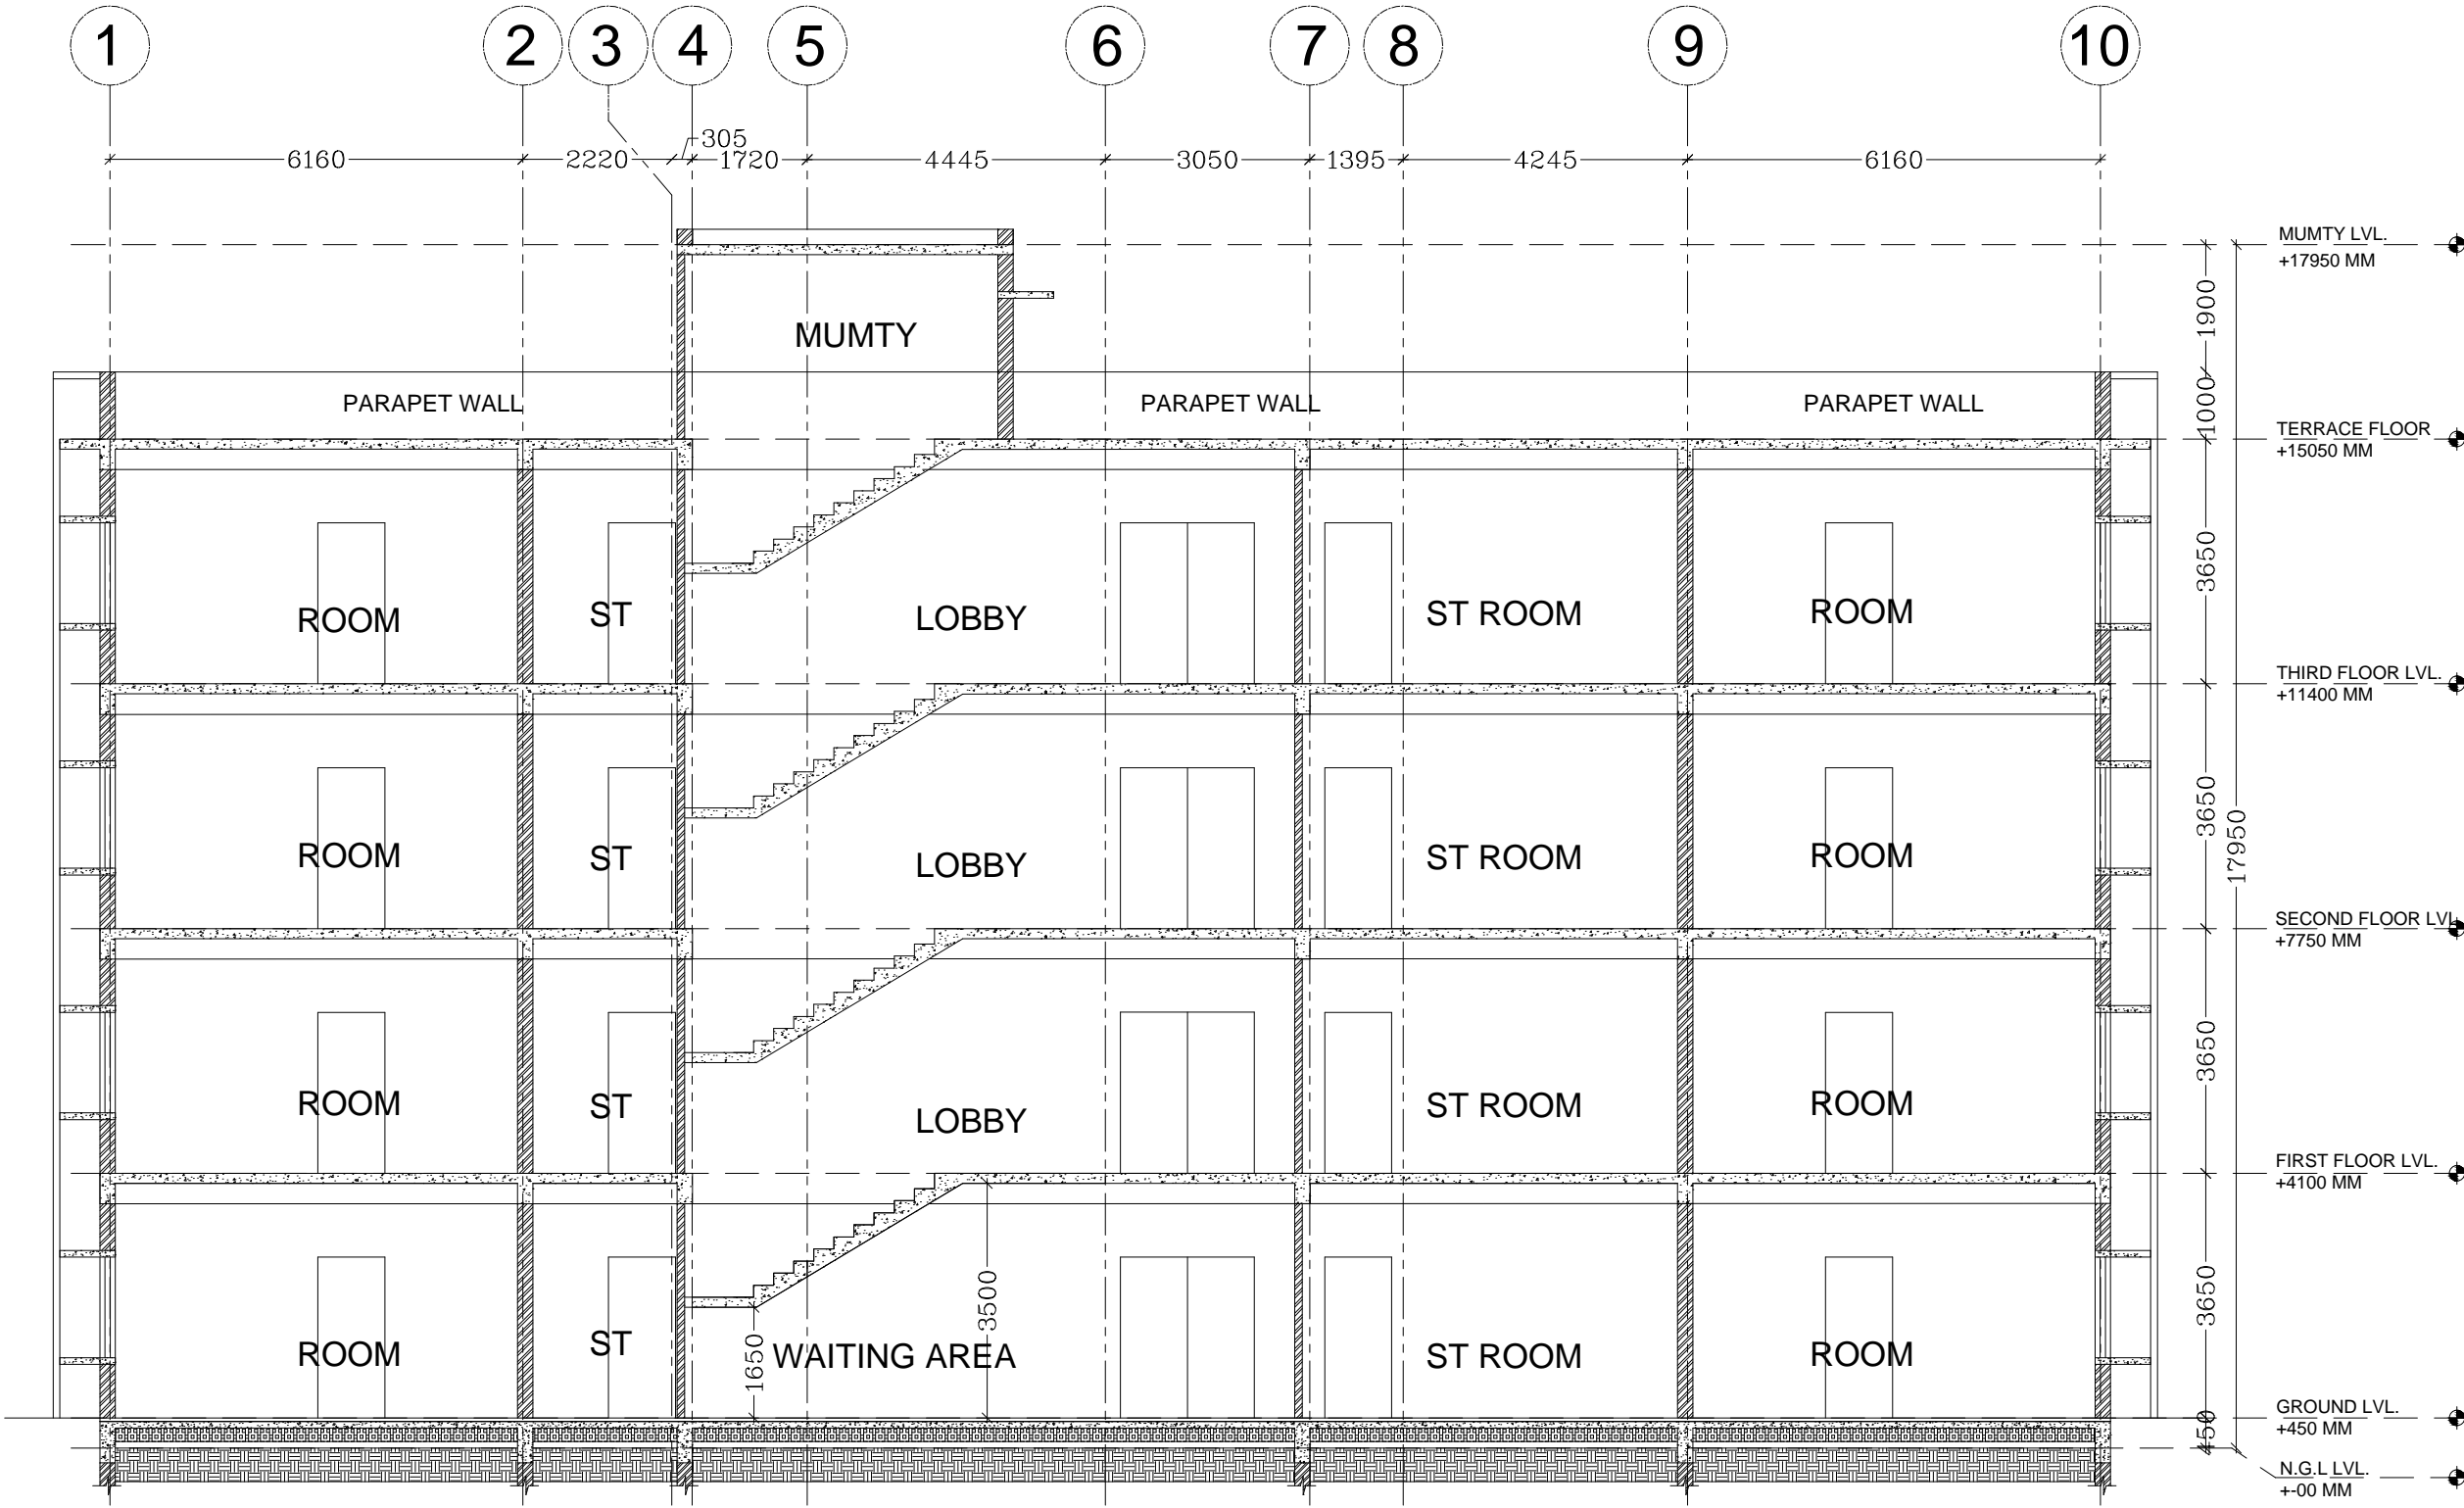

SECTION AA'

REV.	DATE	DESCRIPTION	DRN.	APPROVED BY
OWNER				
TCIL				
PROJECT				
PROPOSED HOSTEL BUILDING (G+3) BLOCK-I NMA, SILVASA				
ARCHITECT				
 <div>MATHUR UGAM & ASSOCIATES A/294,2RD FLOOR, SAFDARJUNG ENCLAVE, NEW DELHI-110029 PH. NO.- (011) 41072283, 26100971 FAX No.:-26185711 Email - mathurugam@gmail.com</div>				
DRAWN BY	DESIGN BY	APPROVED BY	CHECKED BY	
MOHD. SHADAB KHAN	AR. ASHISH MATHUR	AR. ASHISH MATHUR	AR. ASHISH MATHUR	
TITLE				
<u>SECTION</u>				
DRWAING TYPE	SCALE	DRAWING NO.		
TENDER DRAWING	NTS	MUA/AR/SLVSA/GN/04		
DATE OF ISSUE				

NOTES

1. ALL DIMENSIONS ARE IN MM & ELEVATIONS IN METERS UNLESS STATED OTHERWISE.

2. THE DRAWINGS IS THE PROPERTY OF MATHUR UGAM & ASSOCIATES AND NOT TO BE USED OR REPRODUCED WITHOUT THEIR PERMISSION

3. UNLESS NOTED OTHERWISE WINDOW / DOOR/ ROLLING SHUTTER LOCATION SHALL BE AT CENTER BETWEEN GRIDS.


4. THIS DRAWING SHALL BE READ IN CONJUNCTION WITH CONTRACT TERMS AND CONDITIONS, SPECIFICATION AND SCHEDULE OF ITEMS.

IMPORTANT NOTE


1. CONSTRUCTION CAN COMMENCE ONLY AFTER THE VERIFICATION OF LOCATION CO-ORDINATES OF THE BUILDING. THE SAME SHALL BE VERIFIED AT SITE WITH RESPECT TO LATEST PLOT PLAN, APPROVED MECH GAD, ARCHITECTURAL AND CIVIL DRAWINGS.


2. FAN HOOK & CONDUIT PIPE ETC. TO BE PROVIDED WITH THE CONSULTATION OF ELECT. BRANCH.

3.

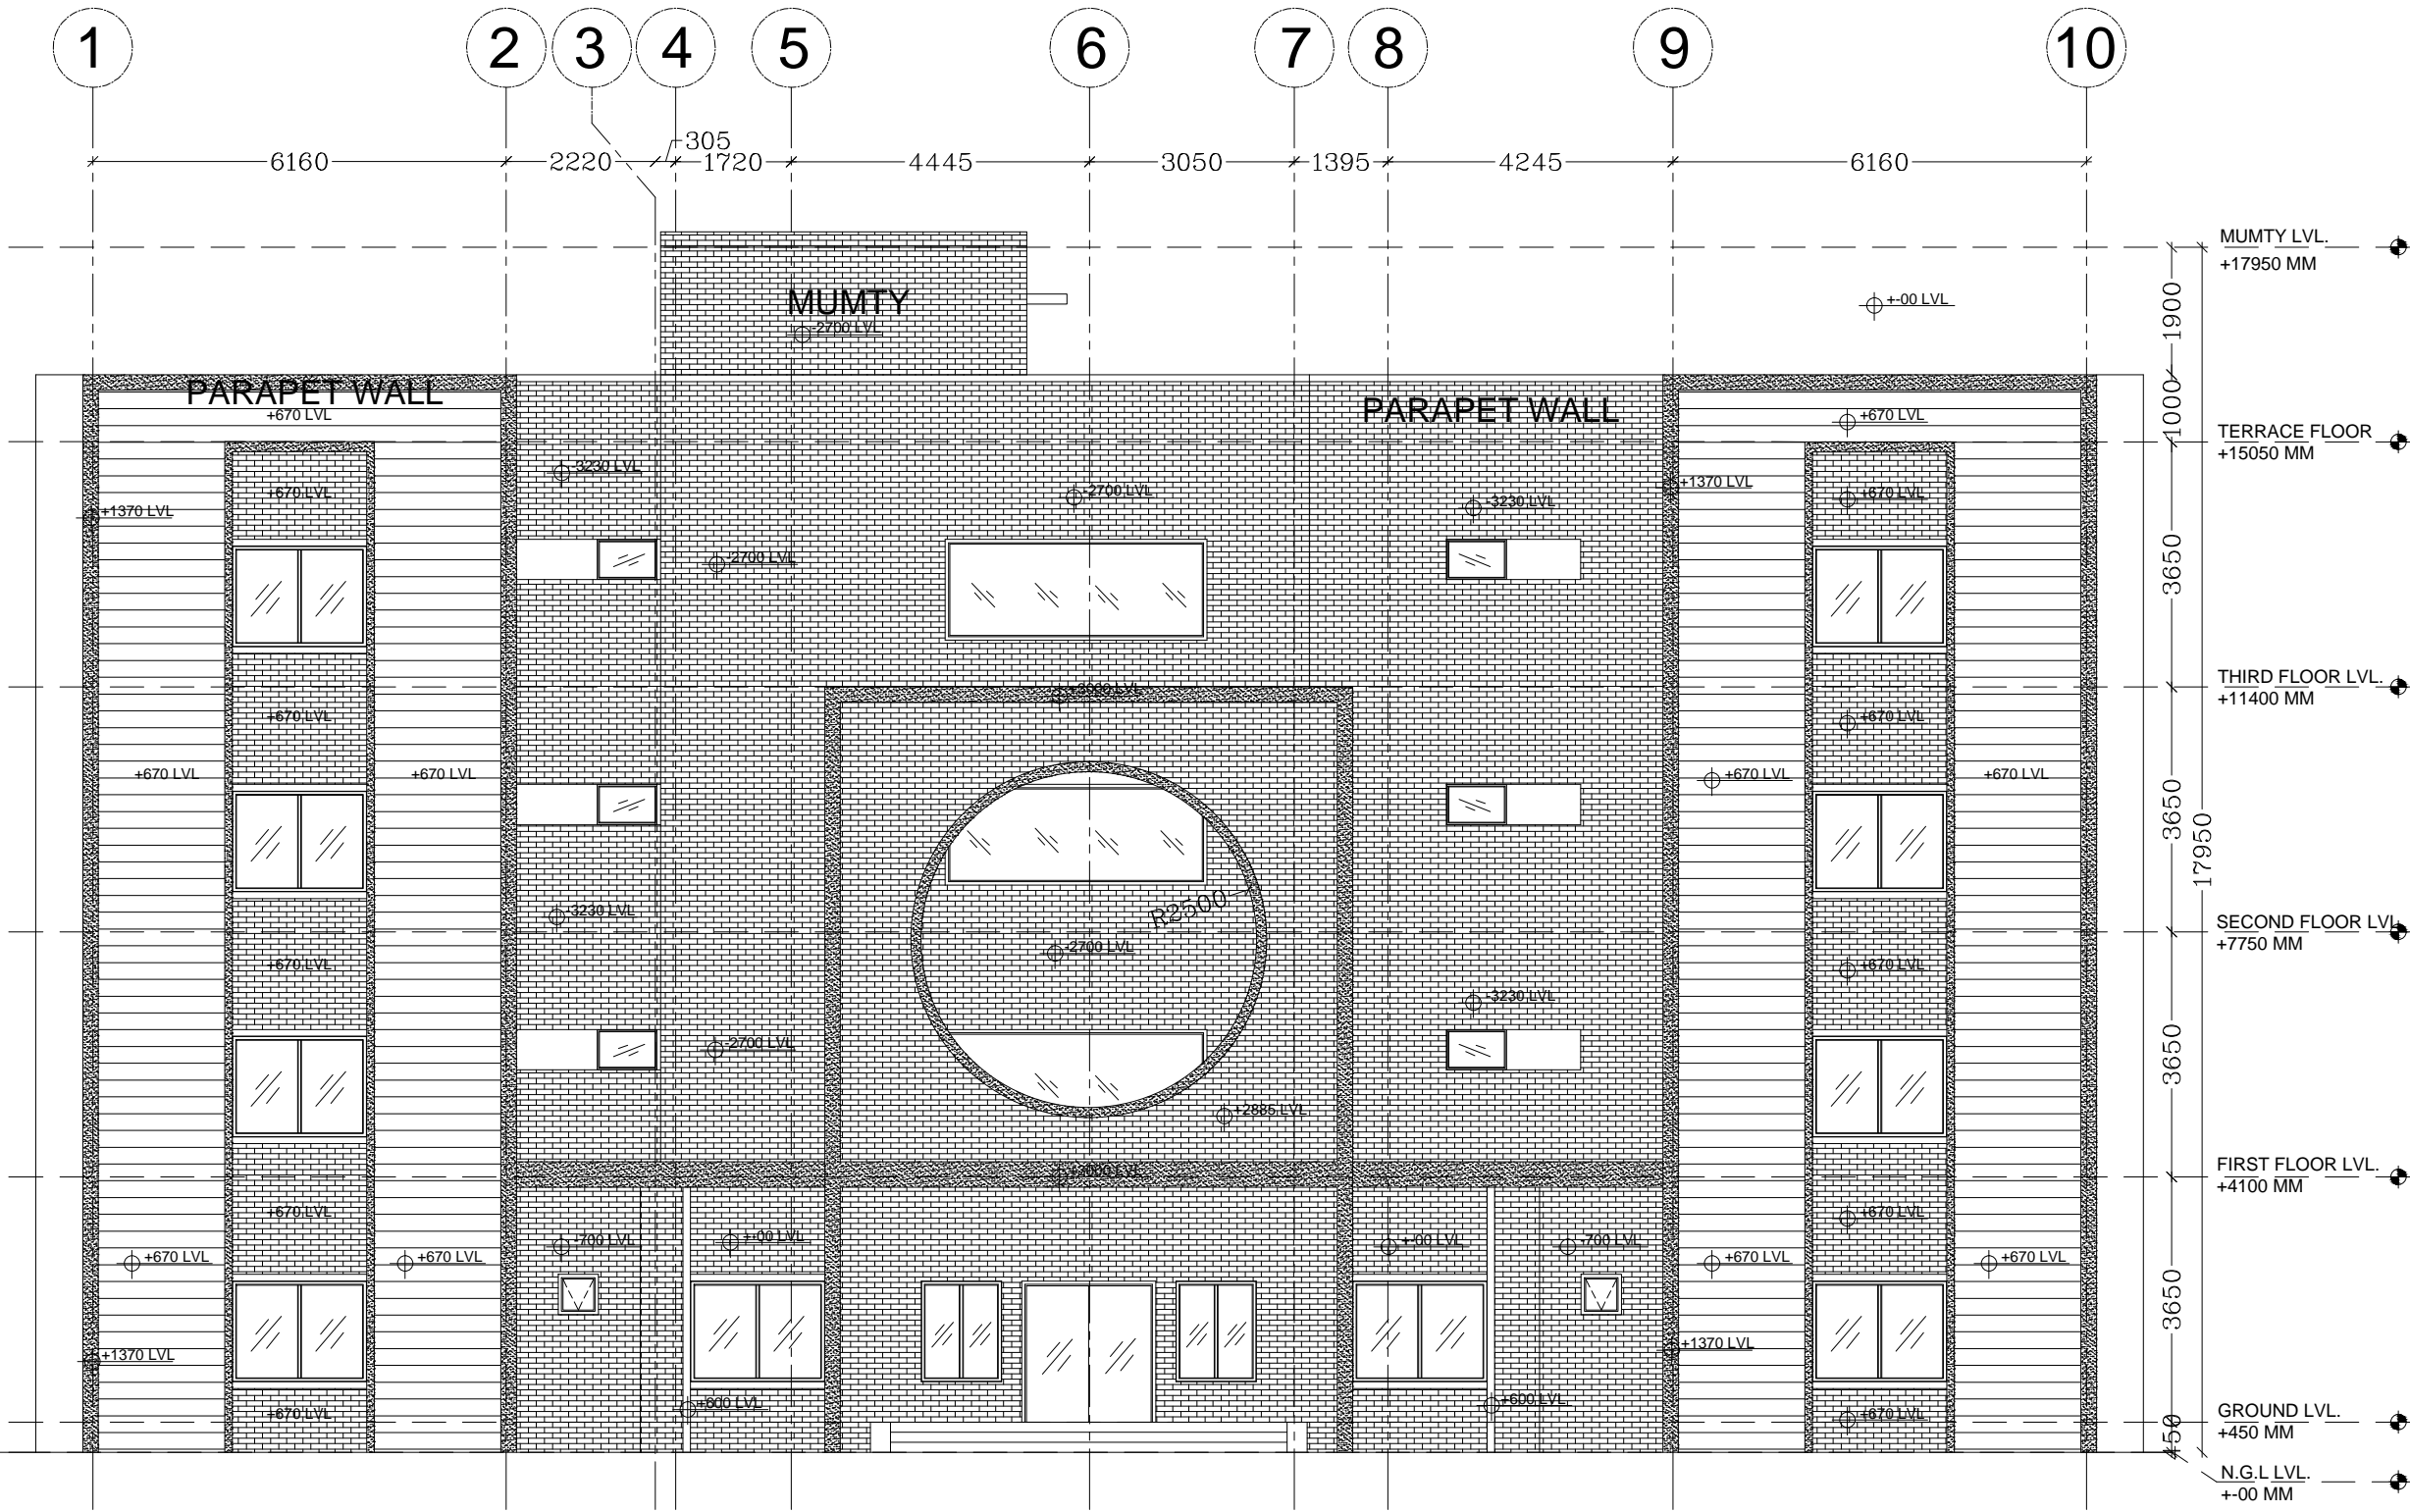

FRONT ELEVATION

REV.	DATE	DESCRIPTION	DRN.	APPROVED BY	
OWNER					
TCIL					
PROJECT					
PROPOSED HOSTEL BUILDING (G+3) BLOCK-I NMA, SILVASA					
ARCHITECT					
 <div>MATHUR UGAM & ASSOCIATES A/294,2RD FLOOR, SAFDARJUNG ENCLAVE, NEW DELHI-110029 PH. NO.- (011) 41072283, 26100971 FAX No.,-26185711 Email - mathurugam@gmail.com</div>					
DRAWN BY		DESIGN BY		APPROVED BY	
MOHD. SHADAB KHAN		AR. ASHISH MATHUR		AR. ASHISH MATHUR	
TITLE					
FRONT ELEVATION					
DRWAING TYPE		SCALE		DRAWING NO.	
TENDER DRAWING		NTS		MUA/AR/SLVSA/GN/05	
				DATE OF ISSUE	

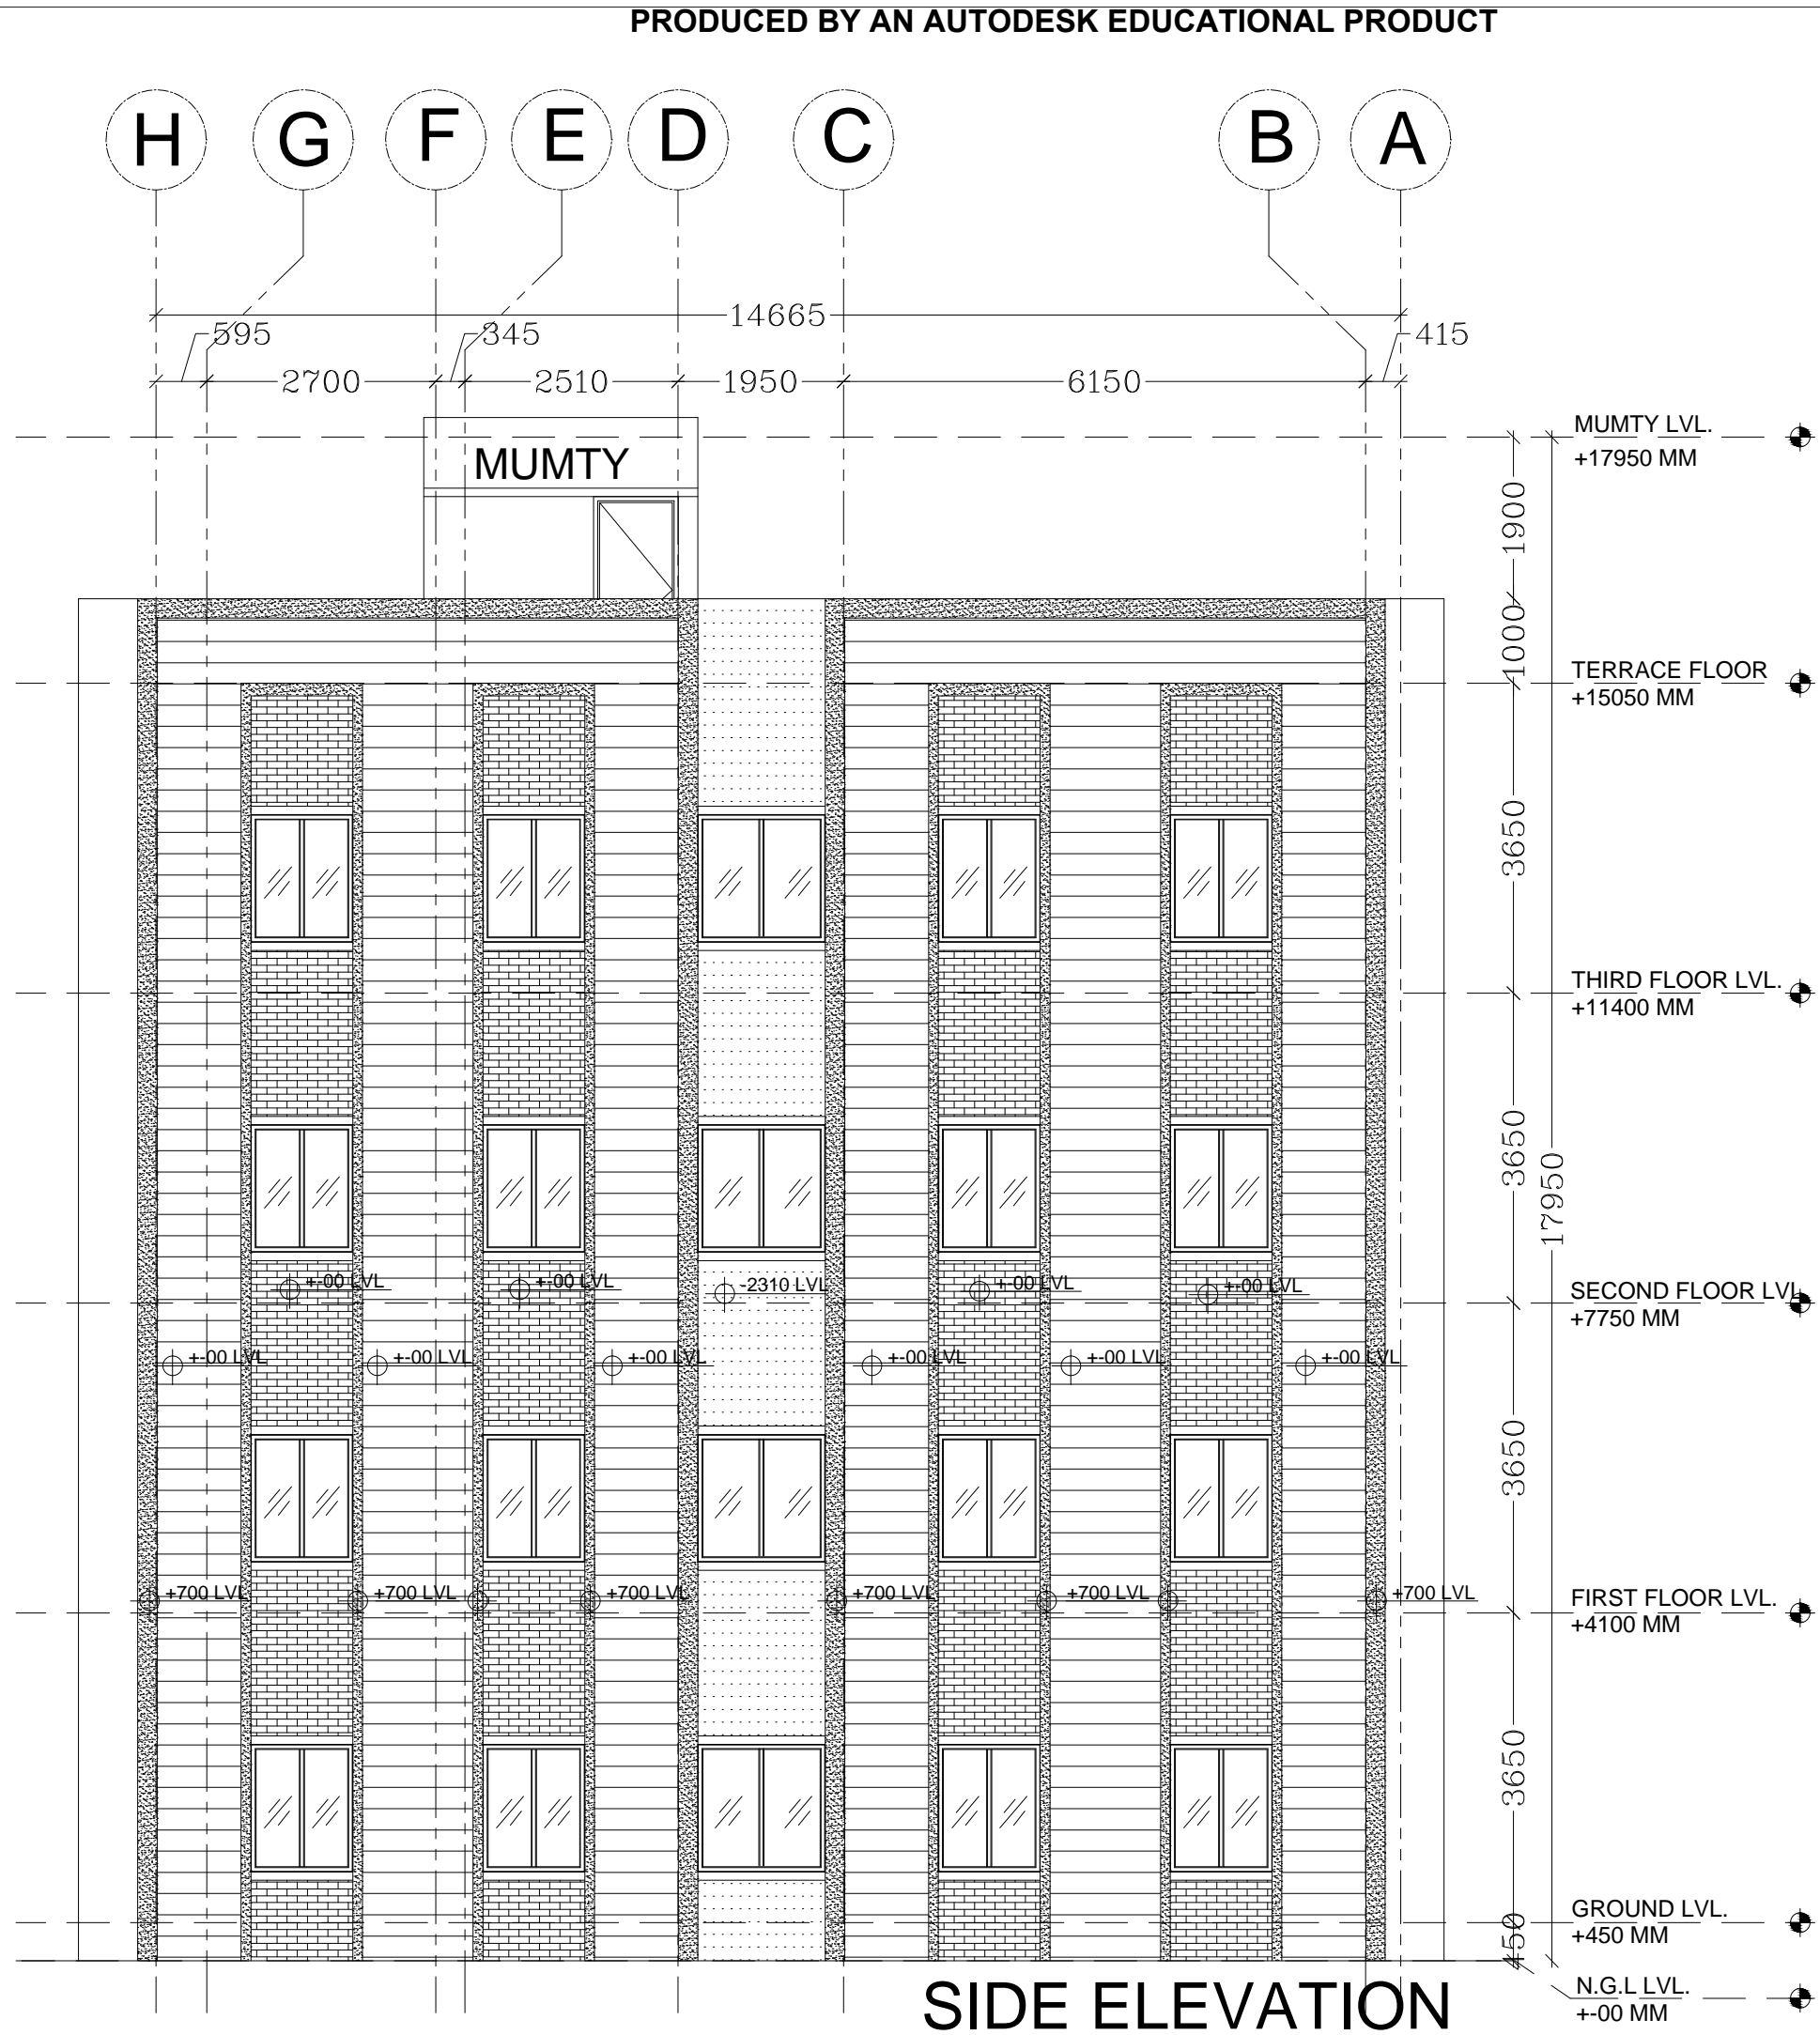


NOTES

1. ALL DIMENSIONS ARE IN MM & ELEVATIONS IN METERS UNLESS STATED OTHERWISE.
2. THE DRAWINGS IS THE PROPERTY OF MATHUR UGAM & ASSOCIATES AND NOT TO BE USED OR REPRODUCED WITHOUT THEIR PERMISSION
3. UNLESS NOTED OTHERWISE WINDOW / DOOR/ ROLLING SHUTTER LOCATION SHALL BE AT CENTER BETWEEN GRIDS.
4. THIS DRAWING SHALL BE READ IN CONJUNCTION WITH CONTRACT TERMS AND CONDITIONS, SPECIFICATION AND SCHEDULE OF ITEMS.

IMPORTANT NOTE

1. CONSTRUCTION CAN COMMENCE ONLY AFTER THE VERIFICATION OF LOCATION CO-ORDINATES OF THE BUILDING. THE SAME SHALL BE VERIFIED AT SITE WITH RESPECT TO LATEST PLOT PLAN, APPROVED MECH. GAD, ARCHITECTURAL AND CIVIL DRAWINGS.
2. FAN HOOK & CONDUIT PIPE ETC. TO BE PROVIDED WITH THE CONSULTATION OF ELECT. BRANCH.
- 3.

REV.	DATE	DESCRIPTION	DRN.	APPROVED BY	
OWNER			TCIL		
PROJECT					
PROPOSED HOSTEL BUILDING (G+3) BLOCK-I NMA, SILVASA					
ARCHITECT					
		MATHUR UGAM & ASSOCIATES A/294,2RD FLOOR, SAFDARJUNG ENCLAVE, NEW DELHI-110029 PH. NO.- (011) 41072283, 26100971 FAX No.-:26185711 Email - mathurugam@gmail.com			
DRAWN BY	DESIGN BY	APPROVED BY	CHECKED BY		
MOHD. SHADAB KHAN	AR. ASHISH MATHUR	AR. ASHISH MATHUR	AR. ASHISH MATHUR		
TITLE					
SIDE ELEVATION					
DRWAING TYPE		SCALE	DRAWING NO.		
TENDER DRAWING		NTS	MUA/AR/SLVSA/GN/06		
			DATE OF ISSUE		

SIDE ELEVATION

NOTES

1. ALL DIMENSIONS ARE IN MM & ELEVATIONS IN METERS UNLESS STATED OTHERWISE.

2. THE DRAWINGS IS THE PROPERTY OF MATHUR UGAM & ASSOCIATES AND NOT TO BE USED OR REPRODUCED WITHOUT THEIR PERMISSION

3. UNLESS NOTED OTHERWISE WINDOW / DOOR/ ROLLING SHUTTER LOCATION SHALL BE AT CENTER BETWEEN GRIDS.


4. THIS DRAWING SHALL BE READ IN CONJUNCTION WITH CONTRACT TERMS AND CONDITIONS, SPECIFICATION AND SCHEDULE OF ITEMS.

IMPORTANT NOTE


1. CONSTRUCTION CAN COMMENCE ONLY AFTER THE VERIFICATION OF LOCATION CO-ORDINATES OF THE BUILDING. THE SAME SHALL BE VERIFIED AT SITE WITH RESPECT TO LATEST PLOT PLAN, APPROVED MECH GAD, ARCHITECTURAL AND CIVIL DRAWINGS.

2. FAN HOOK & CONDUIT PIPE ETC. TO BE PROVIDED WITH THE CONSULTATION OF ELECT. BRANCH.

3.

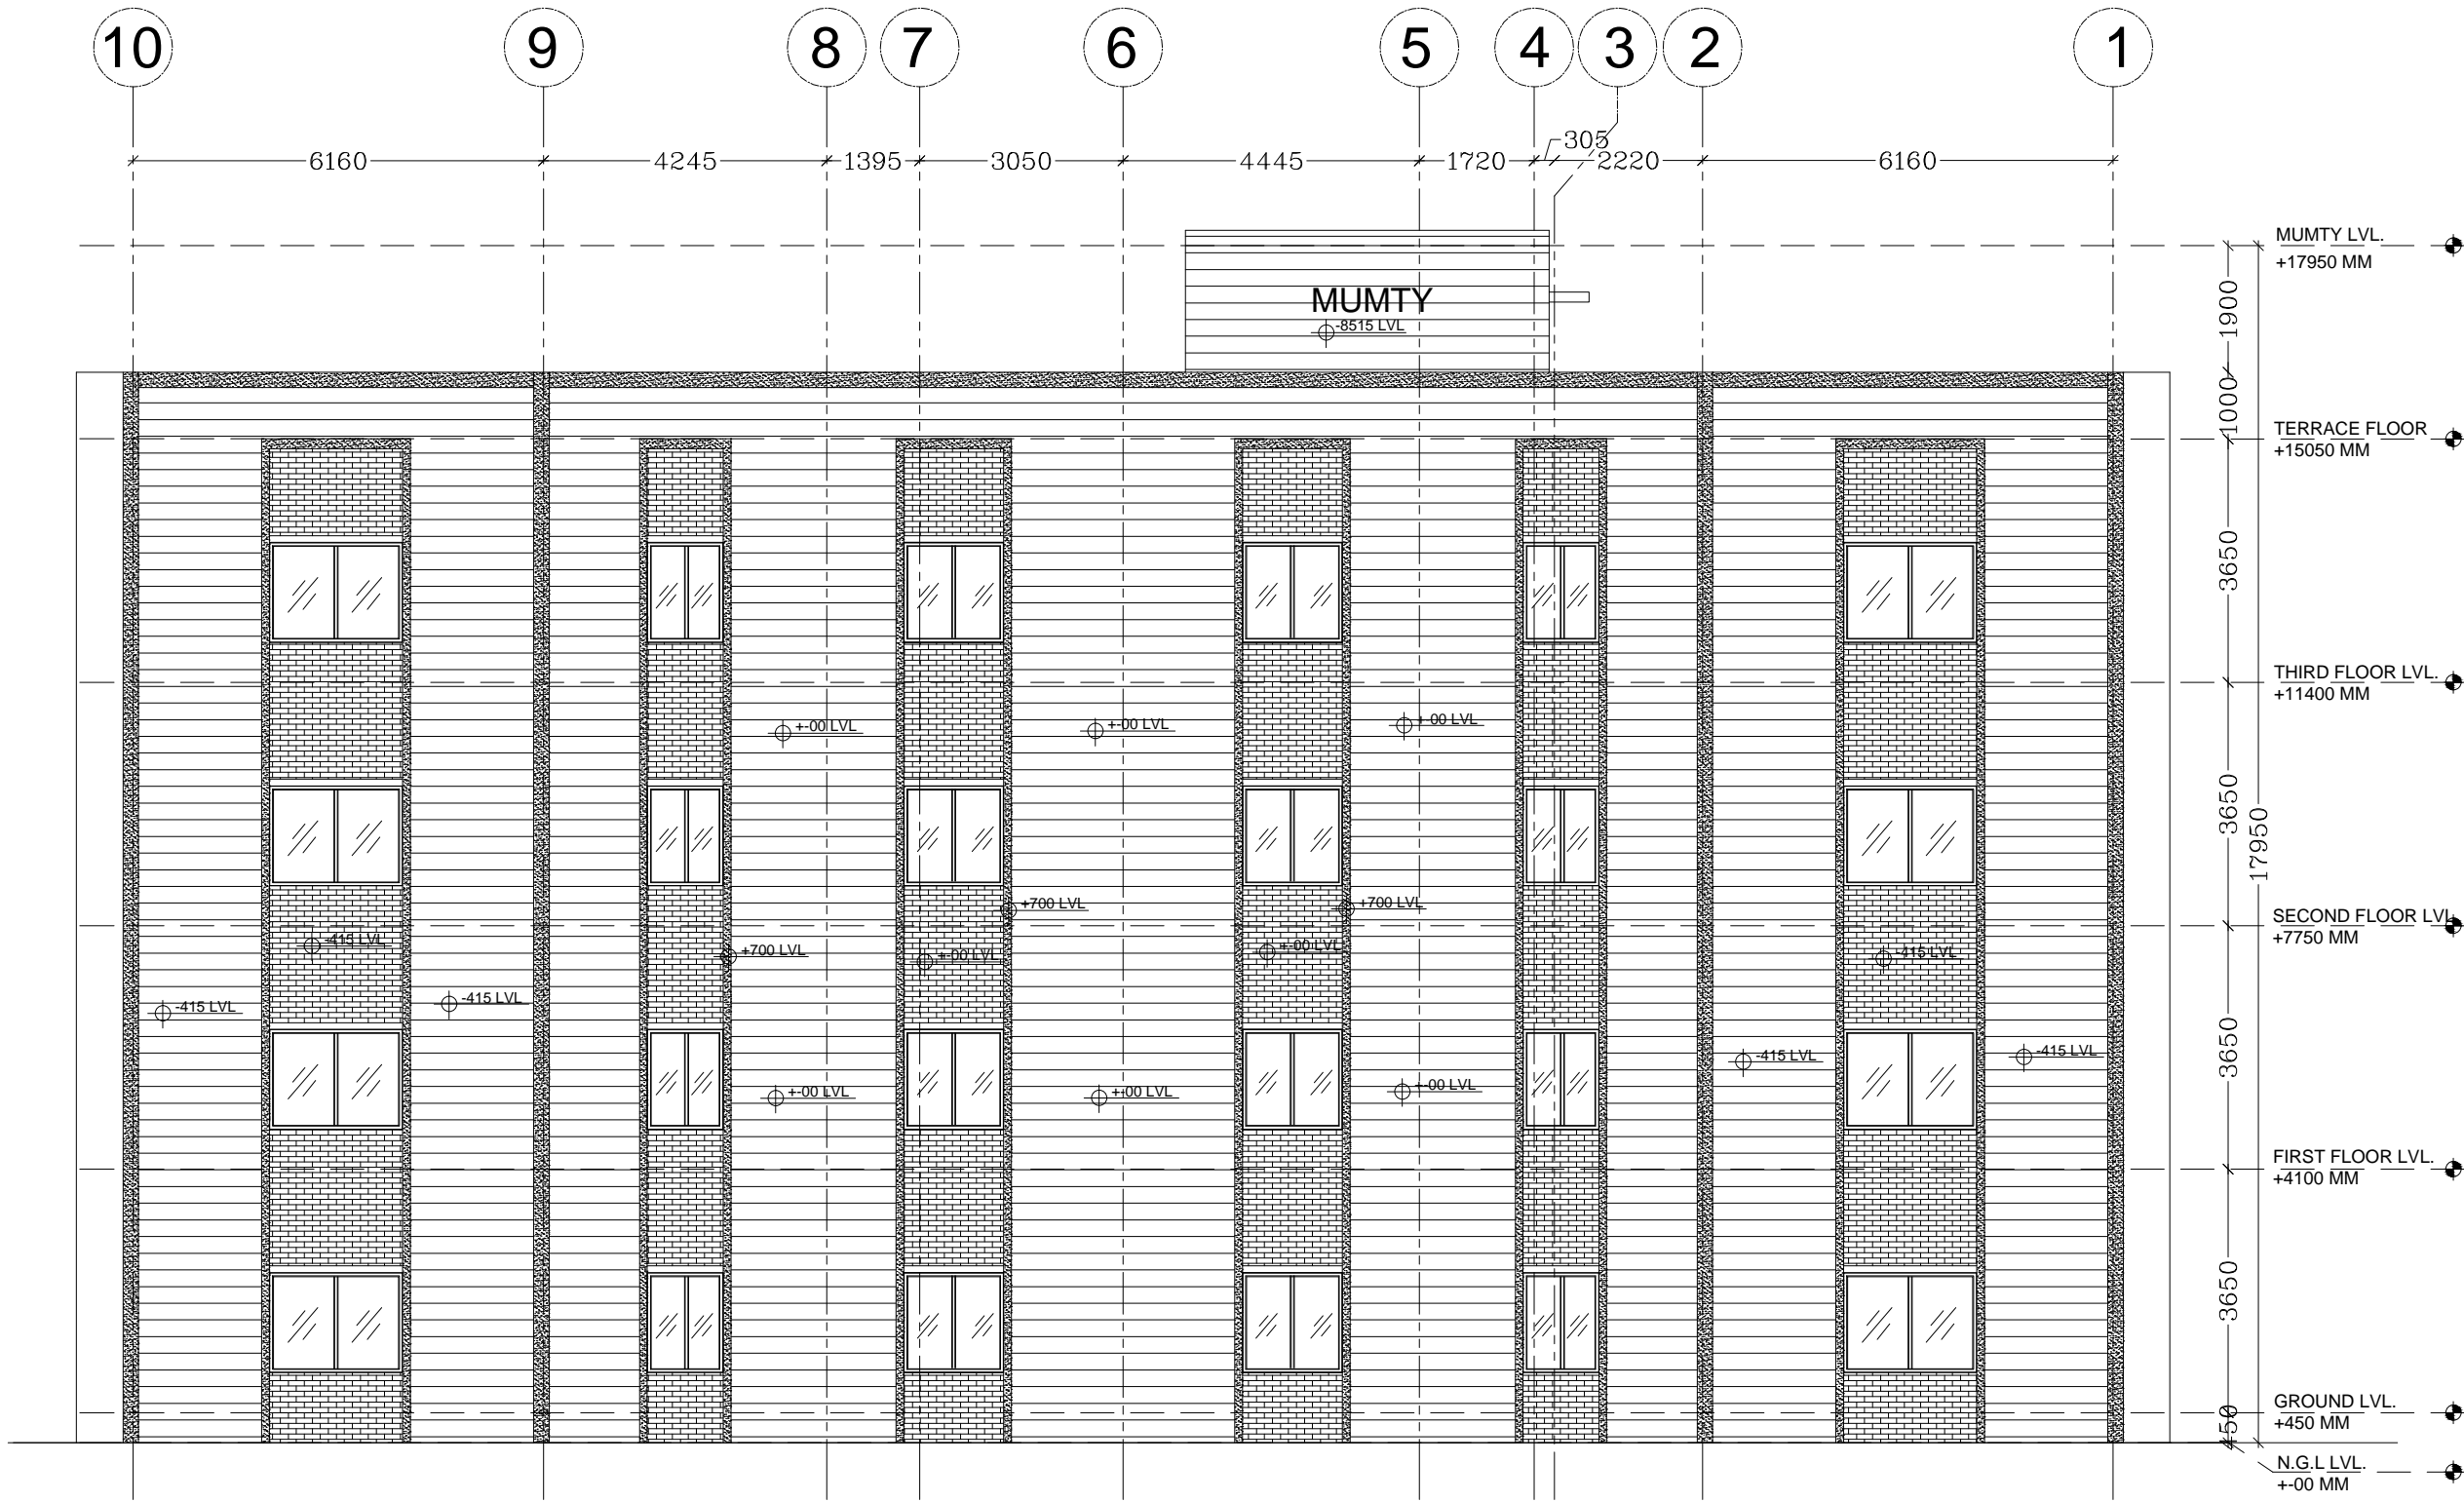

BACK ELEVATION

REV.	DATE	DESCRIPTION	DRN.	APPROVED BY	
OWNER					
TCIL					
PROJECT					
PROPOSED HOSTEL BUILDING (G+3) BLOCK-I NMA, SILVASA					
ARCHITECT					
 <div>MATHUR UGAM & ASSOCIATES A/294,2RD FLOOR, SAFDARJUNG ENCLAVE, NEW DELHI-110029 PH. NO.- (011) 41072283, 26100971 FAX No.-:26185711 Email - mathurugam@gmail.com</div>					
DRAWN BY		DESIGN BY	APPROVED BY	CHECKED BY	
MOHD. SHADAB KHAN		AR. ASHISH MATHUR	AR. ASHISH MATHUR	AR. ASHISH MATHUR	
TITLE					
BACK ELEVATION					
DRWAING TYPE			SCALE	DRAWING NO.	
TENDER DRAWING			NTS	MUA/AR/SLVSA/GN/07	
				DATE OF ISSUE	